
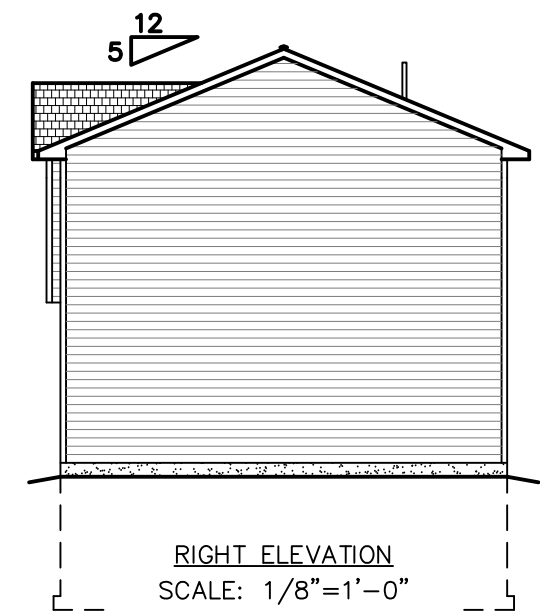
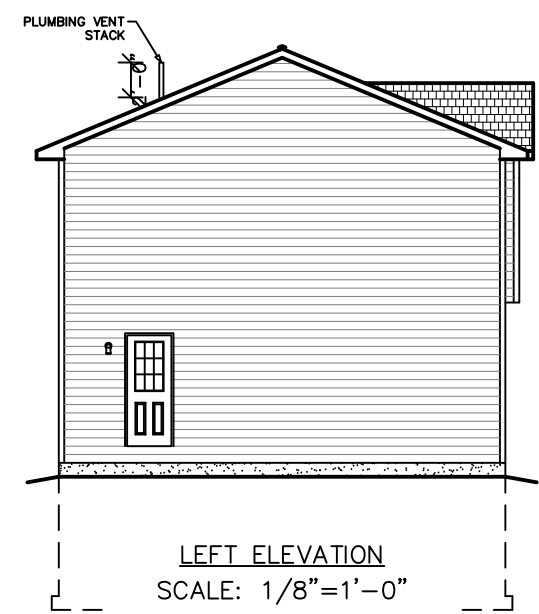


OVERHANG DIMENSION (*)			
ROOF PITCH	HOUSE WIDTH		
	24'-0"	26'-0"/30'-0"	27'-8"/31'-8"
5/12	16"	11"	16"
7/12	16"	11"	16"
9/12	12"	11"	12"
12/12	8 3/4"	8 3/4"	8 3/4"

NOTE:
WINDOW GRILLE PATTERNS SHOWN ARE FOR ANDERSEN WINDOWS.
GRILLE PATTERNS FOR OTHER MANUFACTURERS MAY BE DIFFERENT.

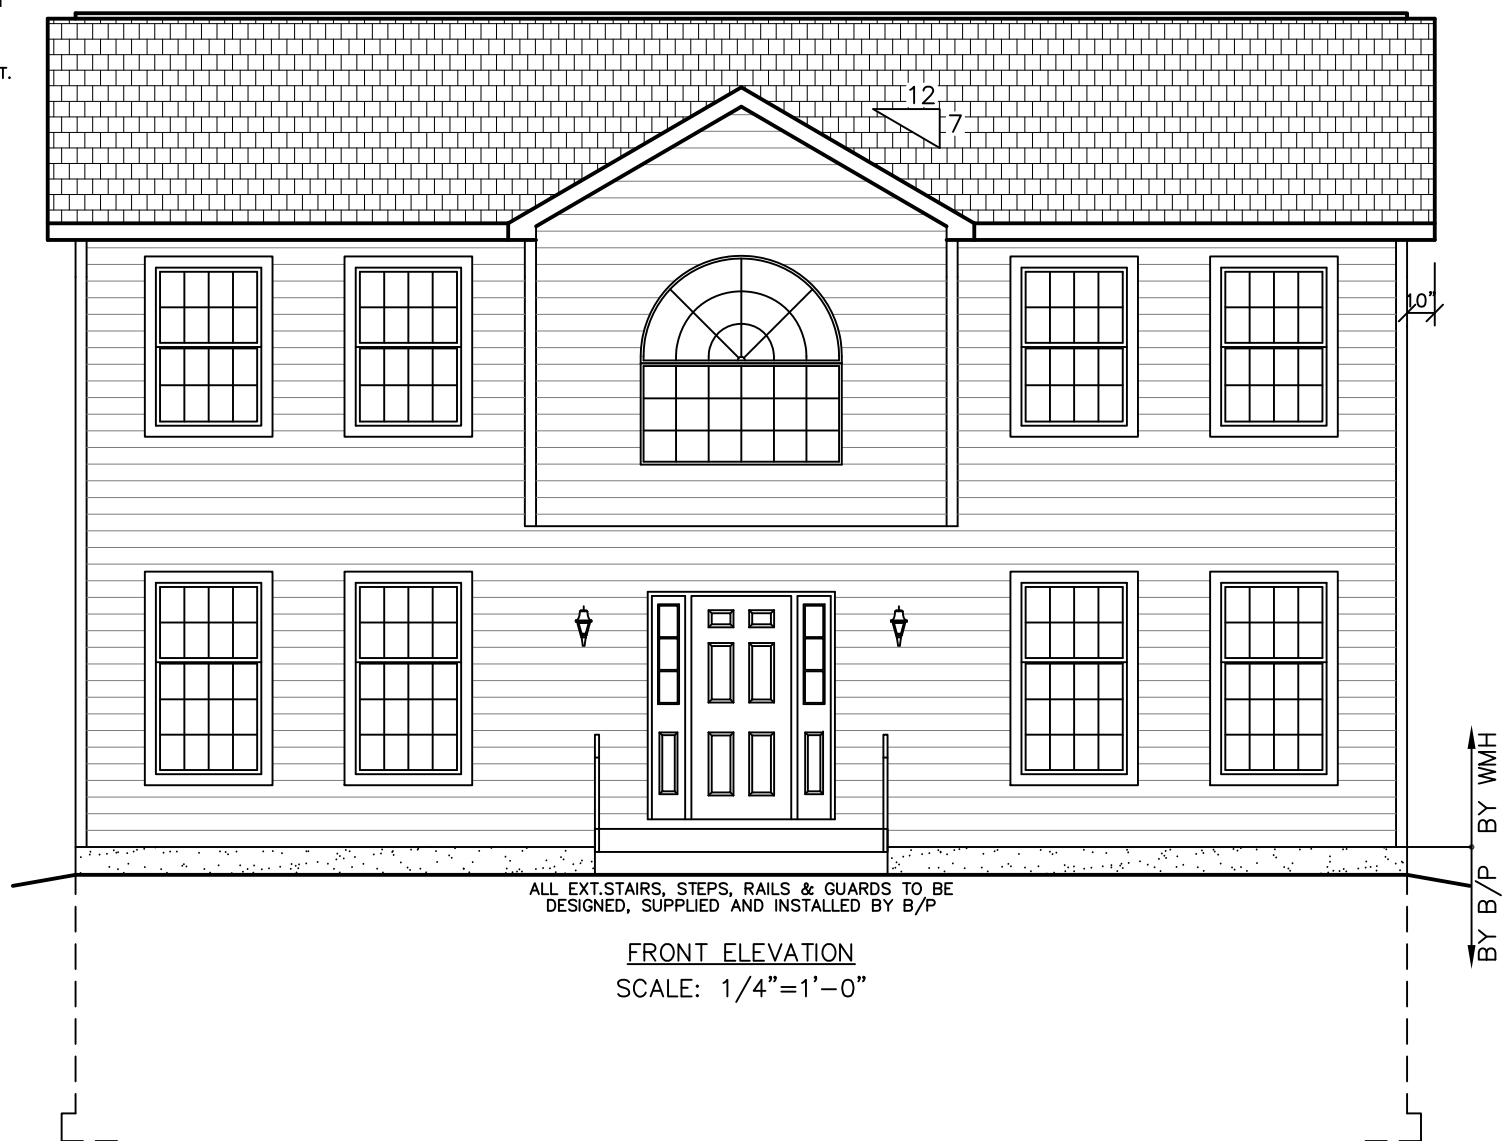


SEE STANDARD NOTES & DETAILS DWG #8

USE GROUP:		BUILDER:		HOMEOWNER:		THIRD PARTY INSPECTION AGENCY:	
CONST. TYPE:		SITE:		SERIAL No.		PE / RA	
DESIGNER:	DATE:	REVISION	DATE	PRODUCTION No.	CHECK	DATE	
SCALE:	AS NOTED						
PAGE:	1	V. GIORGIO	10/12/07				


MAYFIELD STD-L ELEVATIONS


Westchester Modular Homes Inc
30 Reagans Mill Road, Wingdale, New York, 12594
Tel (845)832-9400 Fax (845)832-6698

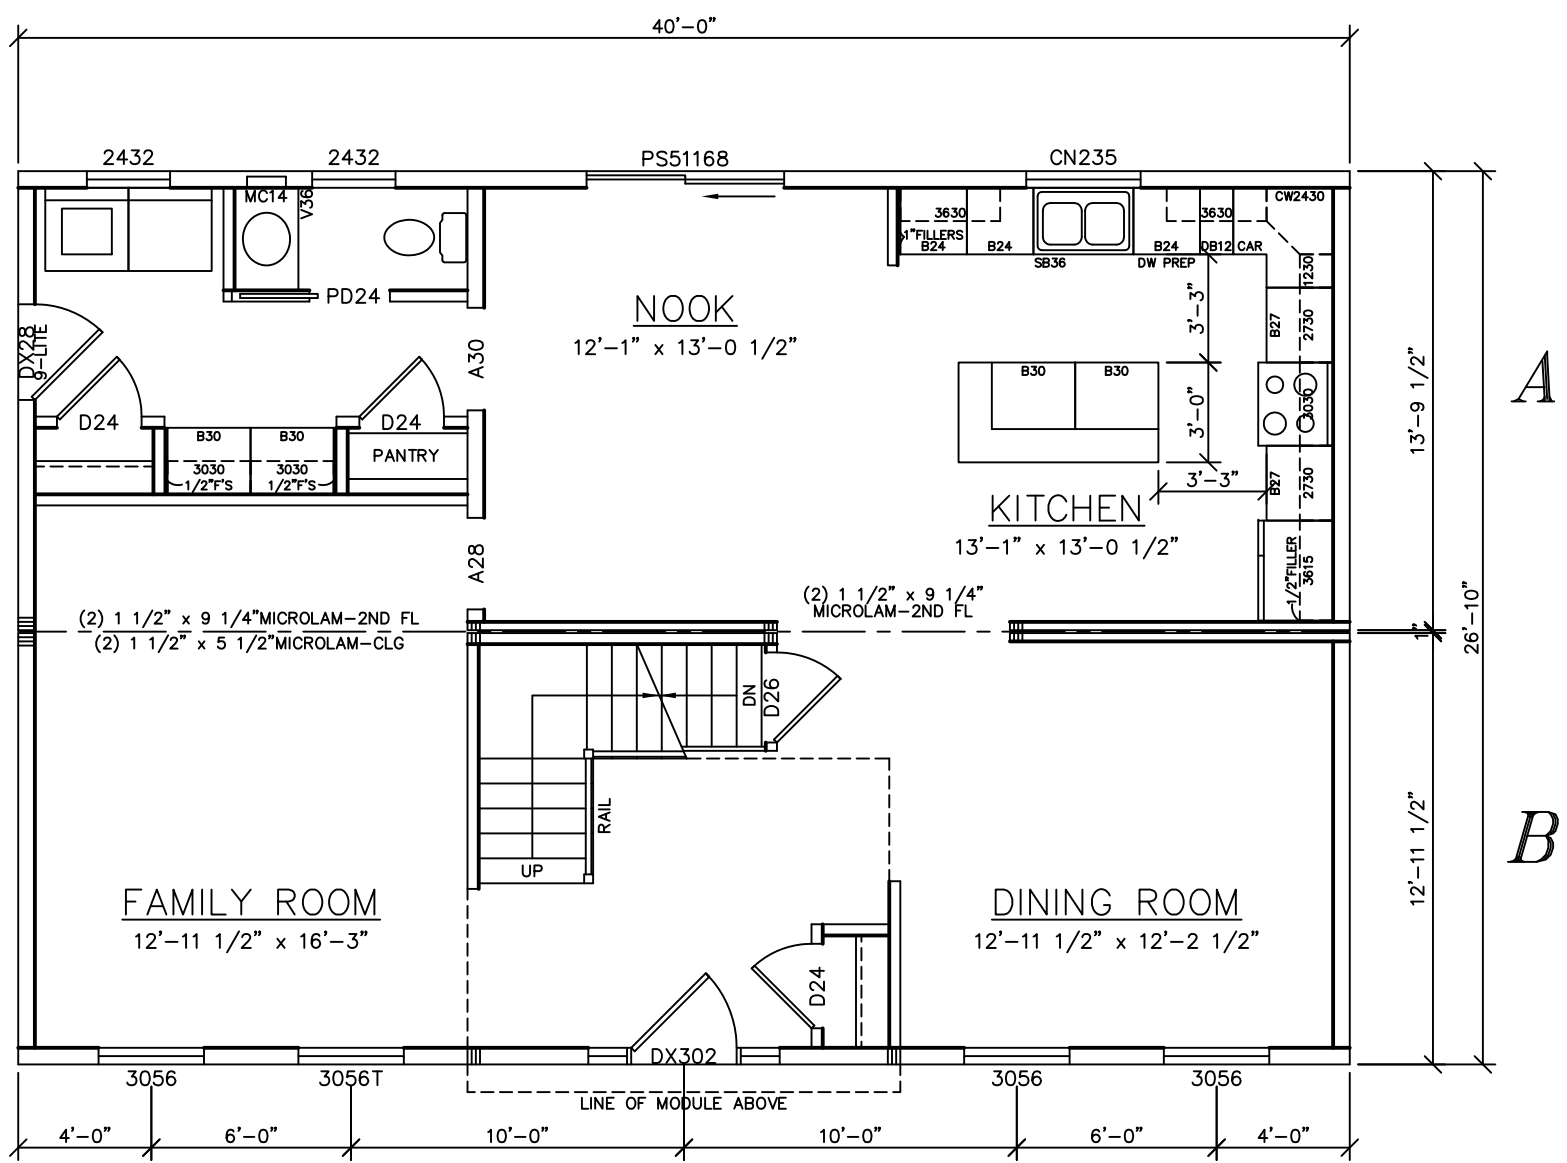

LIGHT & VENTILATION SCHEDULE (SF)			
ROOM	AREA	LIGHT SUPPLIED	VENT SUPPLIED
FAMILY ROOM	211	25.8	11.46
DINING ROOM	158	25.8	11.46
KITCHEN	171	8.0	7.40
NOOK	158	30.4	14.60

SEE STANDARD NOTES & DETAILS DWG #8

USE GROUP: CONST. TYPE:	BUILDER: HOMEOWNER: SITE:	SERIAL No. PRODUCTION No.	PE / RA THIRD PARTY INSPECTION AGENCY
MAYFIELD STD-L FIRST FLOOR PLAN		REVISION DATE	CHECK DATE
 Westchester Modular Homes Inc 30 Reagans Mill Road, Wingdale, New York, 12594 Tel (845)832-9400 Fax (845)832-6698		V.GIORGIO 10/21/08	
DESIGNER: DATE: SCALE: 1/4" = 1'-0" PAGE:		3A	

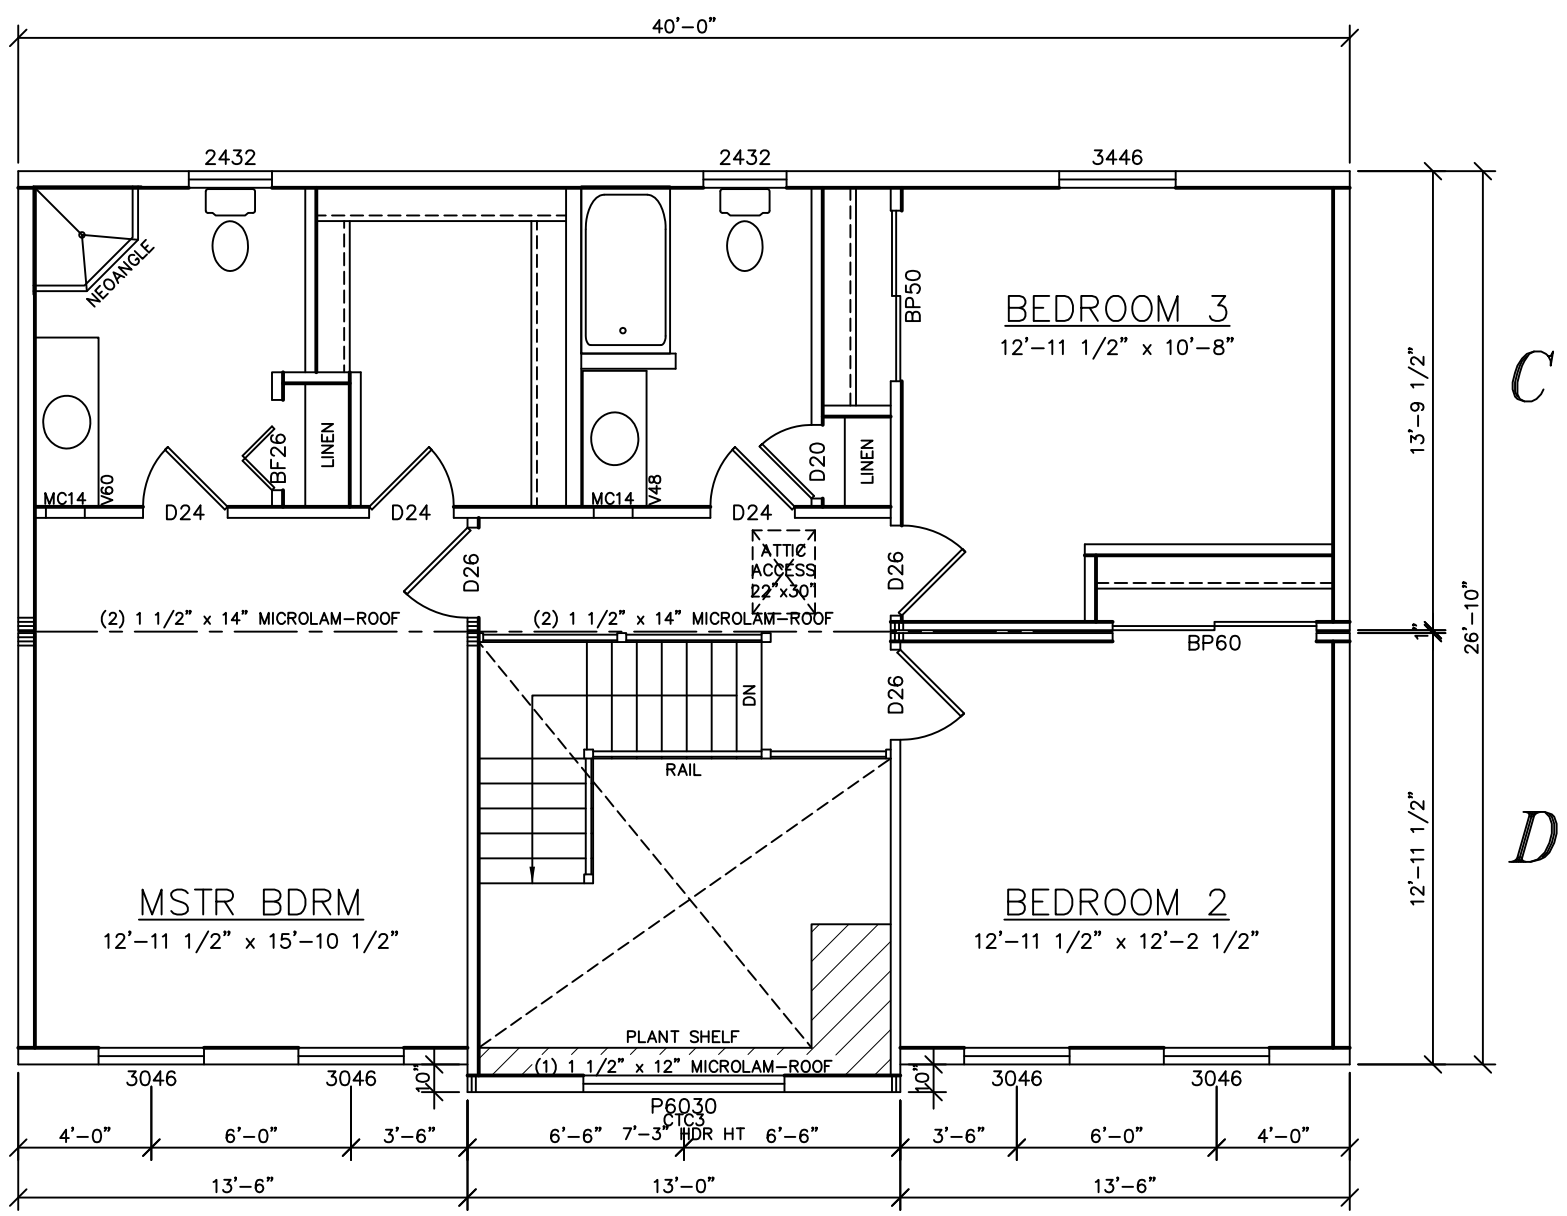

LIGHT & VENTILATION SCHEDULE (SF)			
ROOM	AREA	LIGHT SUPPLIED	VENT SUPPLIED
MSTR BDRM	206	20.6	11.46
BEDROOM 2	158	20.6	11.46
BEDROOM 3	138	11.7	6.41

SEE STANDARD NOTES & DETAILS DWG #8

USE GROUP: CONST. TYPE:	HOMEOWNER: SITE:	MAYFIELD SECOND FLOOR PLAN	WESTCHESTER MODULAR HOMES INC 30 REAGANS MILL ROAD, WINGDALE, NEW YORK, 12594 TEL (845)832-9400 FAX (845)832-6698	SERIAL No. PRODUCTION No. REVISION CHECK V.GIORGIO	DATE DATE DATE DATE 10/21/08	THIRD PARTY INSPECTION AGENCY PE / RA
----------------------------	---------------------	--------------------------------------	---	--	--	--