



OVERHANG DIMENSION (*)			
ROOF PITCH	HOUSE WIDTH		
	24'-0"	26'-0"/30'-0"	27'-8"/31'-8"
5/12	16"	11"	16"
7/12	16"	11"	16"
9/12	12"	11"	12"
12/12	8 3/4"	8 3/4"	8 3/4"

NOTE:
WINDOW GRILLE PATTERNS SHOWN ARE FOR ANDERSEN WINDOWS.
GRILLE PATTERNS FOR OTHER MANUFACTURERS MAY BE DIFFERENT.

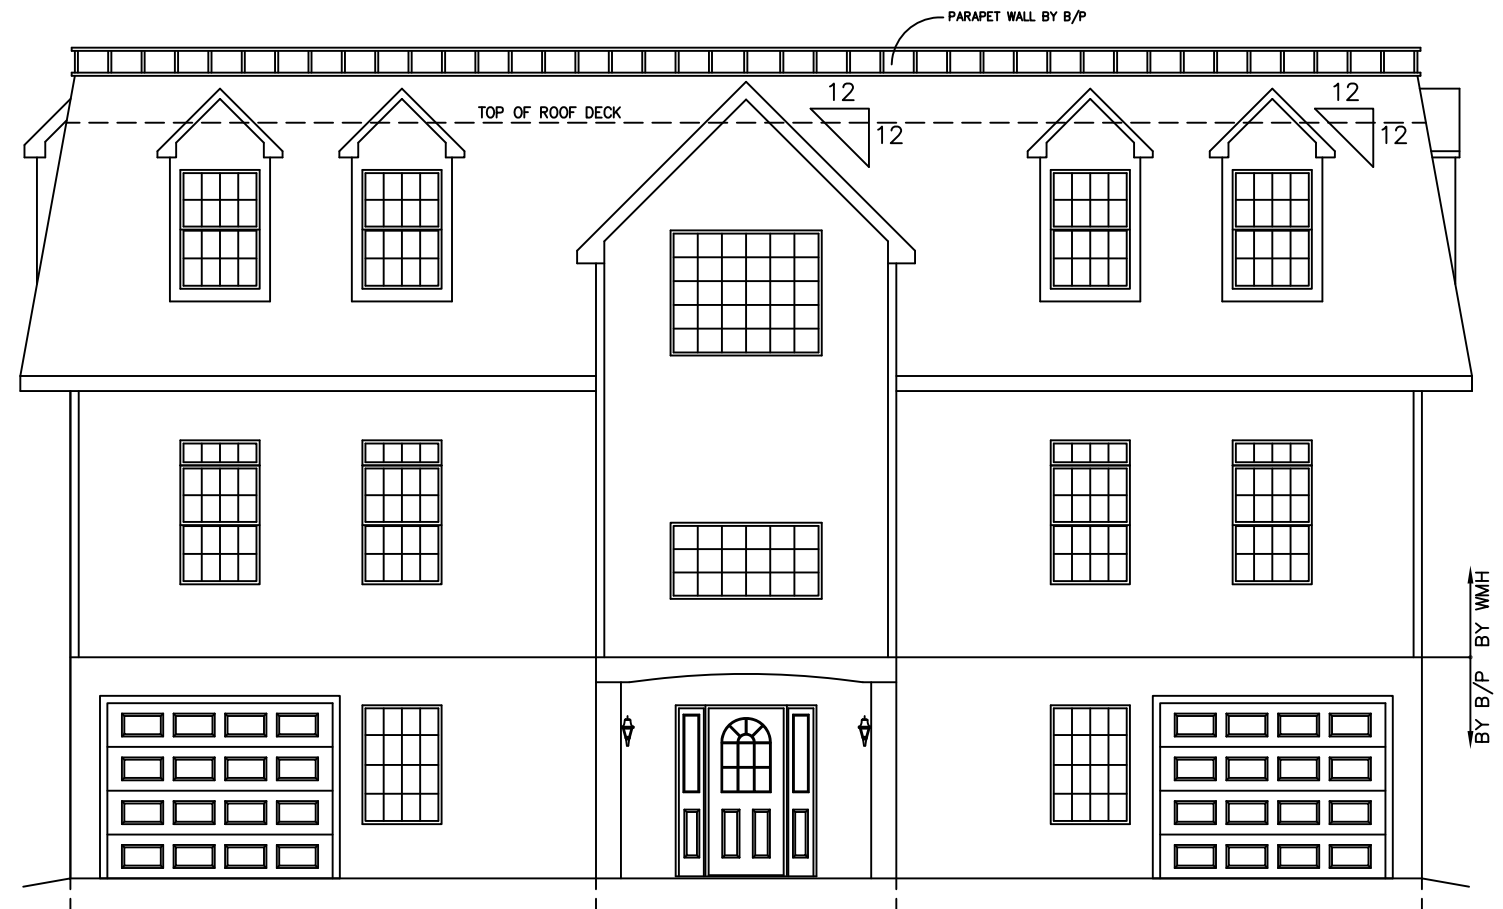


ALL EXT. STAIRS, STEPS, RAILS & GUARDS TO BE DESIGNED, SUPPLIED AND INSTALLED BY B/P
FRONT ELEVATION
SCALE: 3/16"=1'-0"


* DELETE SIDING FRONT ONLY *

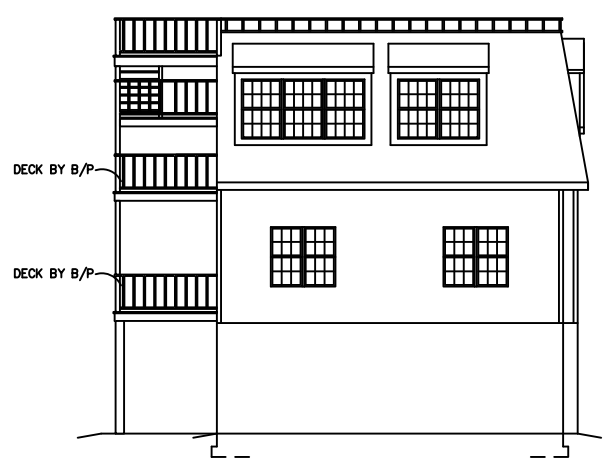

LEFT ELEVATION
SCALE: 3/32"=1'-0"

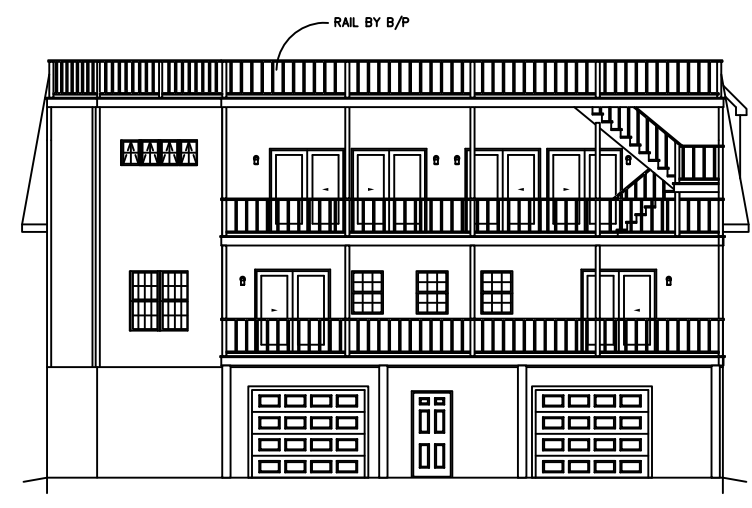

REAR ELEVATION
SCALE: 3/32"=1'-0"

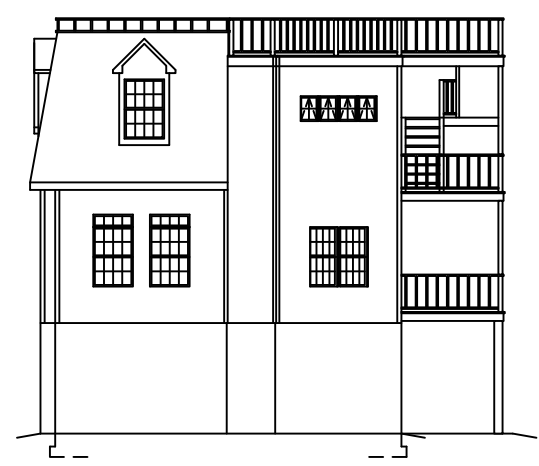

RIGHT ELEVATION
SCALE: 3/32"=1'-0"

SEE STANDARD NOTES & DETAILS DWG #8

THIRD PARTY INSPECTION AGENCY


PE / RA

SERIAL No.	08134
PRODUCTION No.	5446
REVISION	DATE
PRELIMINARY	8/18/08
	10/15/08
CHECK	DATE

BUILDER: HOMEOWNER:


COLONIAL CTN-L
ELEVATIONS

Westchester Modular Homes Inc
30 Reagans Mill Road, Wingdale, New York, 12594
Tel (845)832-9400 Fax (845)832-6698

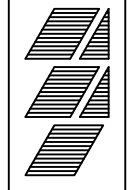


USE GROUP:	R5
CONST. TYPE:	VA
DESIGNER:	P. Walter
DATE:	8/15/08
SCALE:	AS NOTED
PAGE:	1

A
B

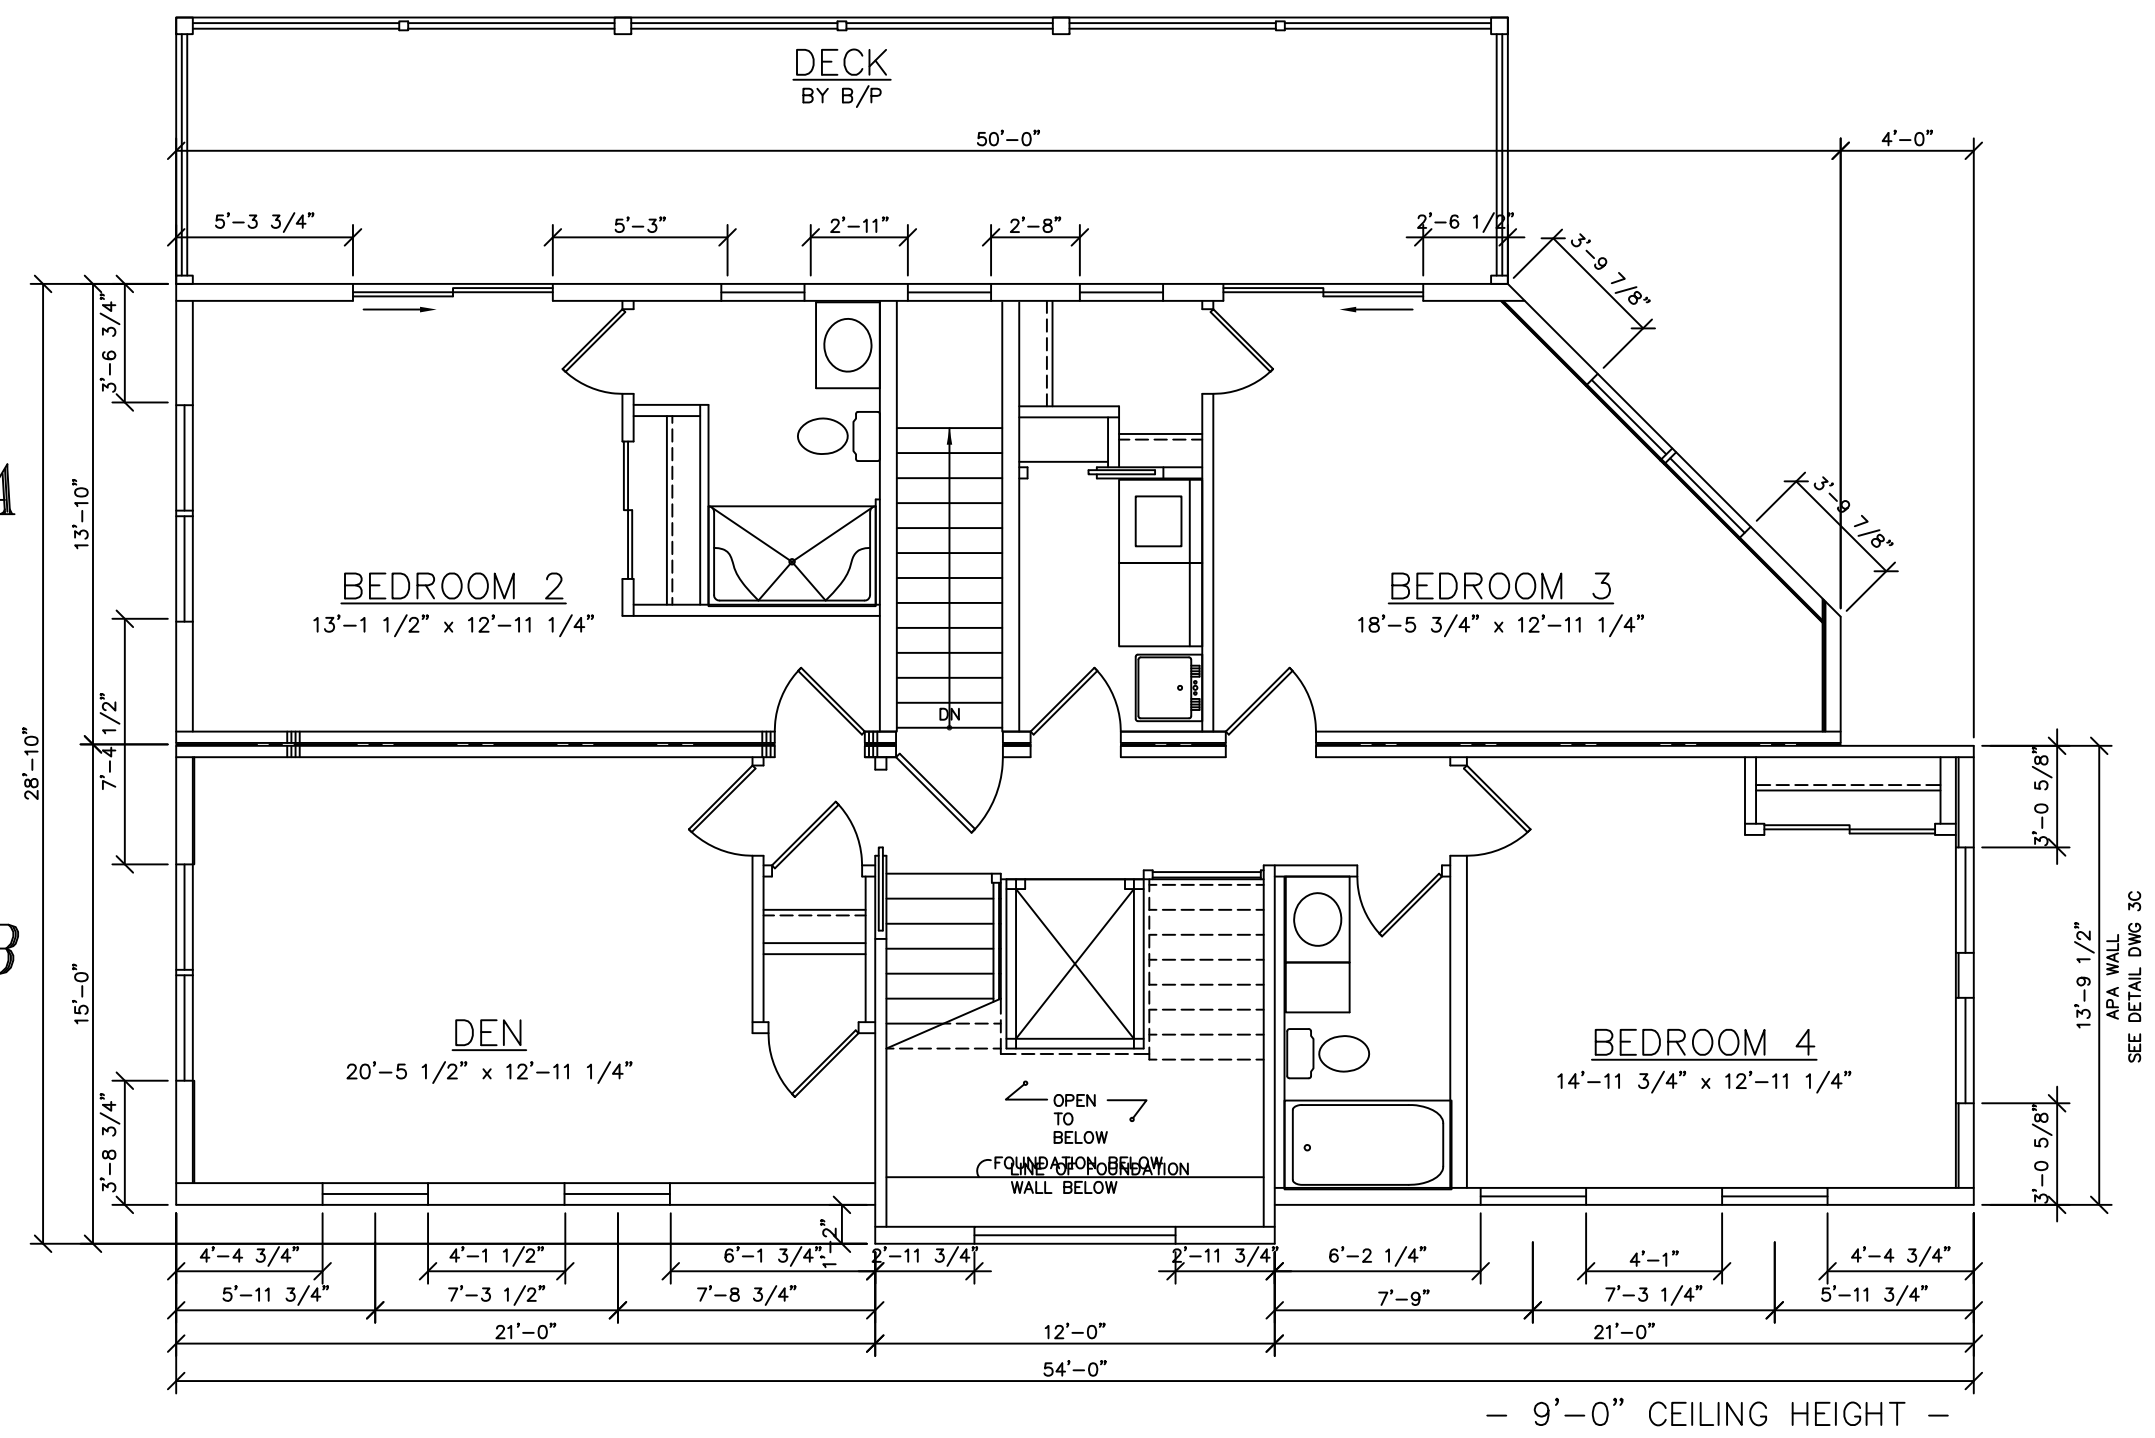

- 9'-0" CEILING HEIGHT -

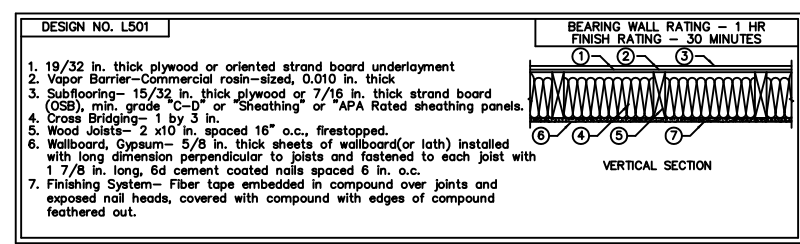

LIGHT & VENTILATION SCHEDULE (SF)			
ROOM	AREA	LIGHT SUPPLIED	VENT SUPPLIED
DEN	265	43.5	22.92
BEDROOM 2	170	42.5	27.57
BEDROOM 3	239	42.5	27.57
BEDROOM 4	194	45.8	22.92

SEE STANDARD NOTES & DETAILS DWG #8
THIRD PARTY INSPECTION AGENCY

PE / RA

SERIAL No. **08134**
PRODUCTION No. **5446**

REVISION	DATE	CHECK	DATE
PRELIMINARY	8/18/08		
	10/15/08		
	11/24/08		
	1/06/09		

HOMEOWNER:

BUILDER:

USE GROUP: **R5**
CONST. TYPE: **VA**


DESIGNER: **P. Watter**
DATE: **8/15/08**
SCALE: **1/4" = 1'-0"**
PAGE: **3A**

COLONIAL CTM-L
FIRST FLOOR PLAN


Westchester Modular Homes Inc
30 Reagans Mill Road, Wingdale, New York, 12594
Tel (845)832-9400 Fax (845)832-6698

C

D

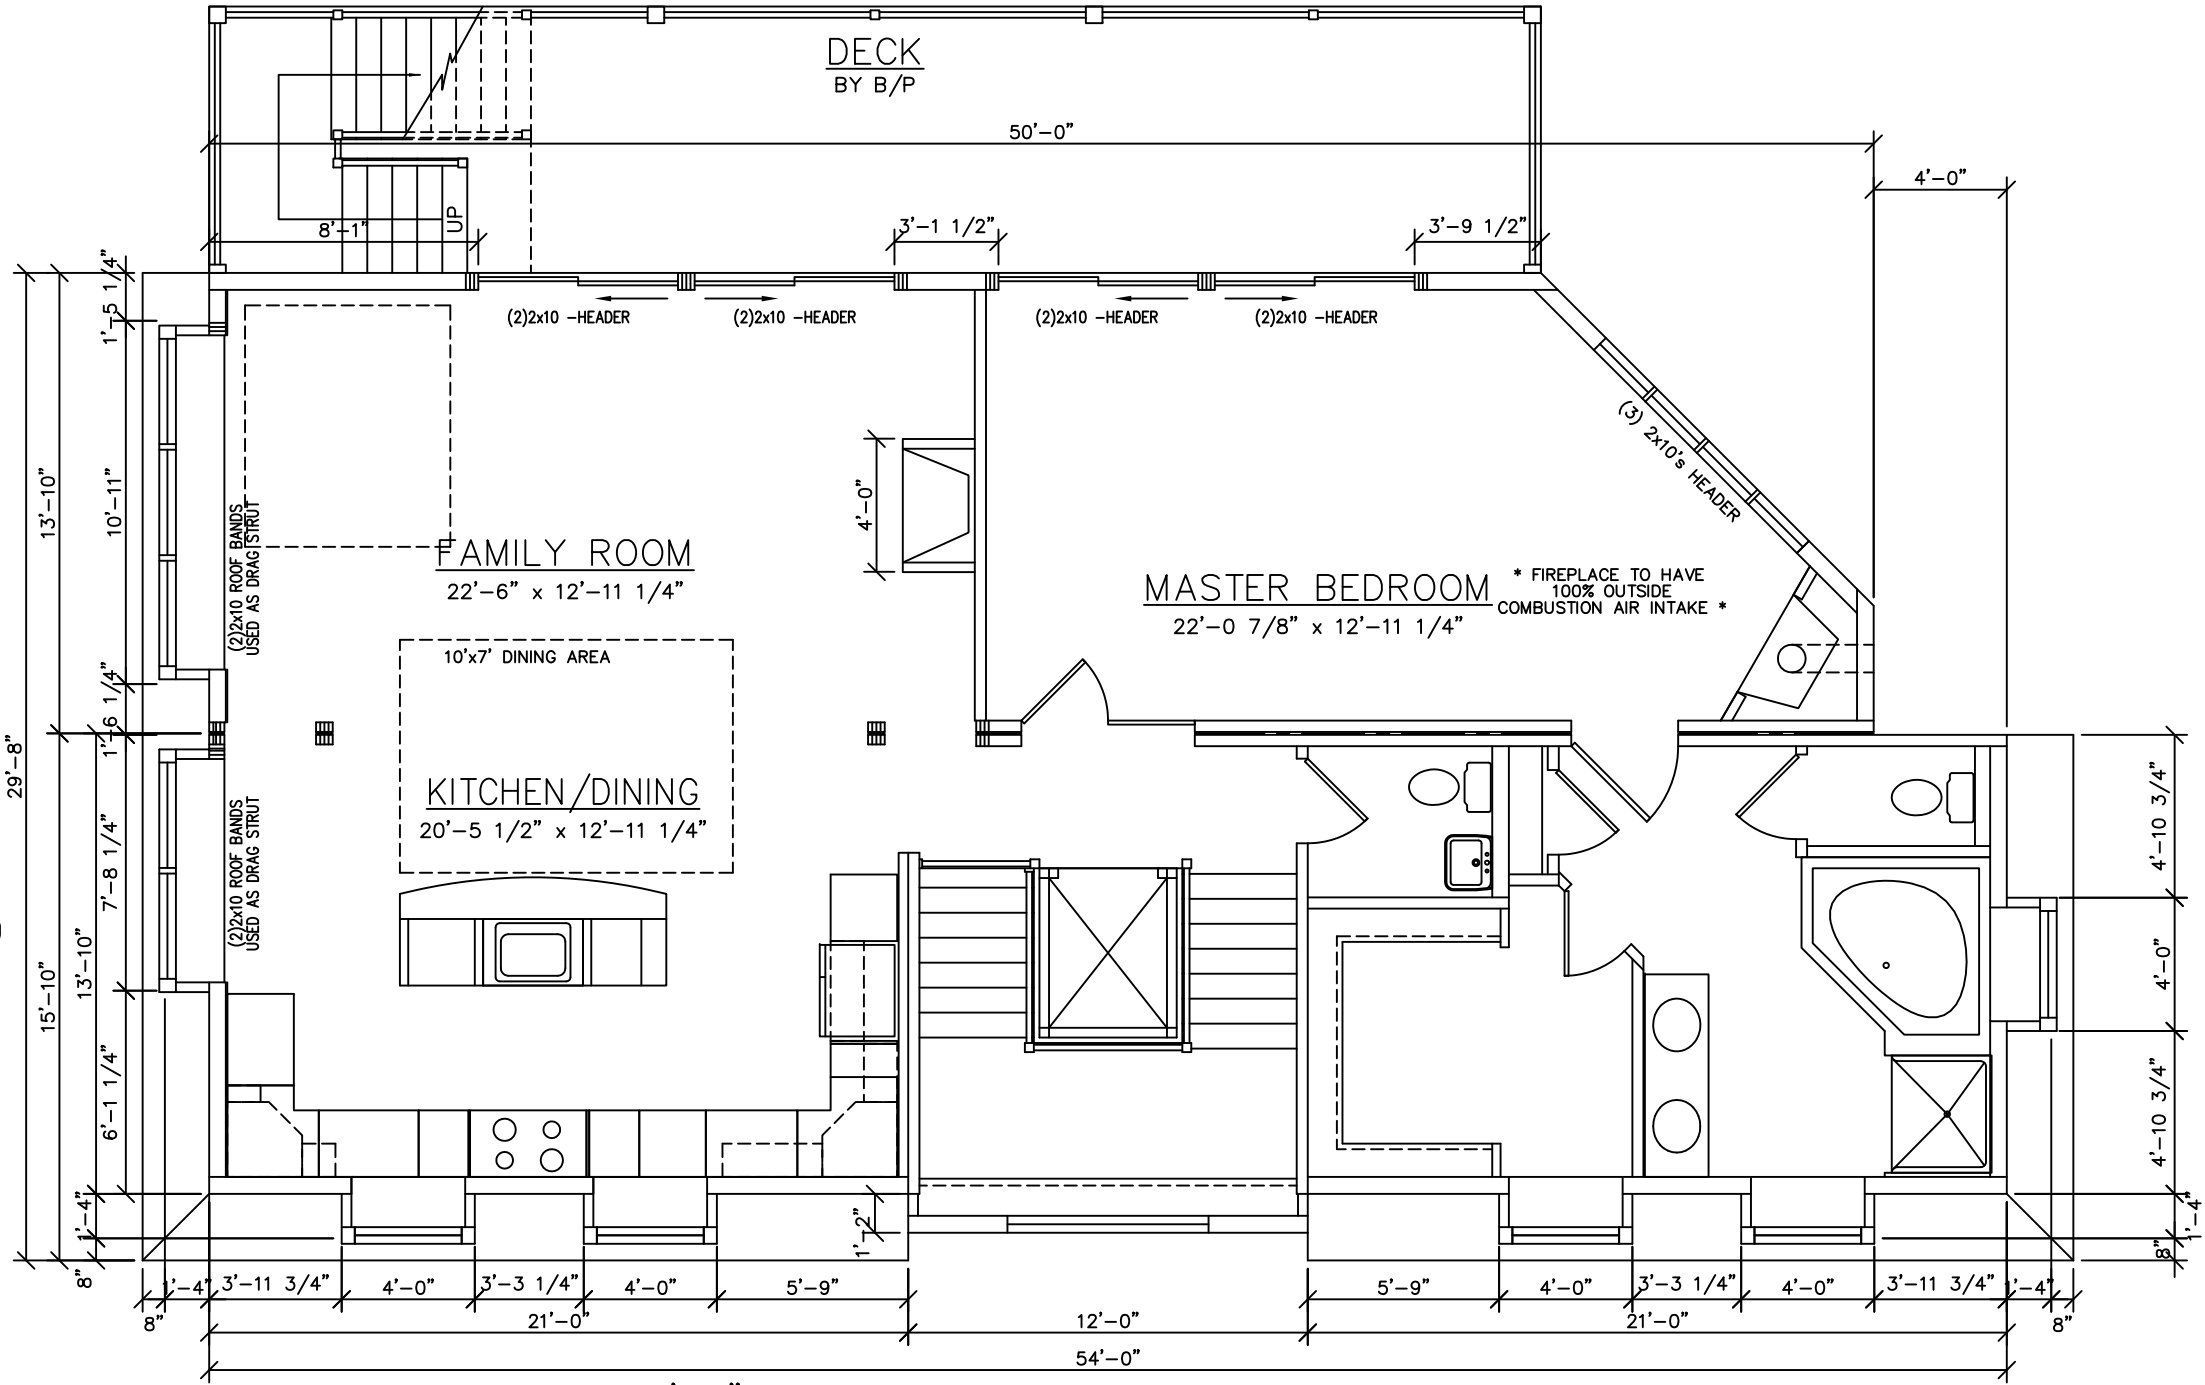

- 9'-0" CEILING HEIGHT -

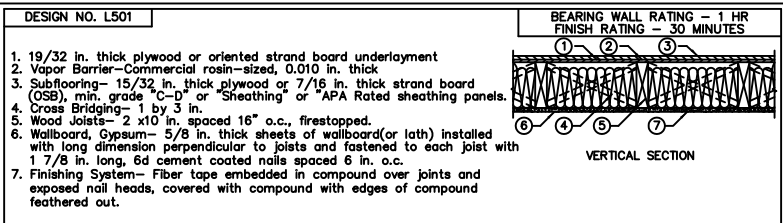

SEE STANDARD NOTES & DETAILS DWG #8

THIRD PARTY INSPECTION AGENCY

PE / RA

SERIAL No. 08134

PRODUCTION No. 5446

REVISION	DATE
PRELIMINARY	8/18/08
	10/15/08
	11/24/08
	1/06/09
CHECK	DATE

HOMEOWNER:

BUILDER:

USE GROUP: R5

CONST. TYPE: VA

DESIGNER: P. Watter

DATE: 8/15/08

SCALE: 1/4" = 1'-0"

PAGE: 3B

COLONIAL CTM-L SECOND FLOOR PLAN

Westchester Modular Homes Inc
30 Reagans Mill Road, Wingdale, New York, 12594
Tel (845)832-9400 Fax (845)832-6698

